



JUSTIN PAUL LUEBBERING
ARCHITECT
A-2013027866

ARCHITECT
YAEGER ARCHITECTURE, INC.

7780 West 118th Street
Overland Park, KS 66213
Tel: (813) 742-8000
Fax: (813) 742-8570
yaegerarchitecture.com

MEP ENGINEER
Henderson Engineers, Inc.

8245 Lenexa Drive, Suite 300
Lenexa, KS 66214
Tel: (913) 742-5000
Fax: (913) 742-5001
www.he-eng.com


STRUCT. ENGINEER
Trabue, Hansen & Hinshaw, Inc.

1901 Pennsylvania Drive
Columbia, MO 65202
Tel: (573) 814-1568
Fax: (573) 814-1128
www.thinc.com


KEYNOTES

KEYNOTES FLOOR PLAN

- 1 INSTALL 5/8" GYP. BD. ON 7/8" FURRING CHANNELS ALONG LIMITS OF CMU AS IDENTIFIED
- 2 DRINKING FOUNTAIN TO BE B1-LEVEL ADA TYPE RE: PLUMBING DWGS.
- 3 RESILIENT CORNERGUARD (CG-1) RE: FINISH SCHEDULE & INTERIOR ELEVATIONS
- 4 INSTALL 5/8" TILE BACKER BD. ON 2-1/2" MTL STUDS @ 16" O.C. ALONG LIMITS OF CMU IN ORDER TO RECEIVE FINISH WALL TILE RE: INTERIOR ELEVATIONS
- 5 PROVIDE CMU KNOCK-OUT PANEL FOR FUTURE ELEV. DR. ACCESS
- 6 1-1/2" WIDE STEEL ROOF ACCESS LADDER (WALL MTD.) RE: AS0411
- 7 MOP SINK RE: PLUMBING DWGS.
- 8 INSTALL 5/8" GYP. BD. ON 1-5/8" MTL STUDS @ 16" O.C. ALONG LIMITS OF CMU AS IDENTIFIED
- 9 ELECTRIC WATER HEATER (WH) RE: PLUMB. DWGS.
- 10 EXPANSION TANK (ET) RE: PLUMB. DWGS.
- 11 INSTALL FRP TO HEIGHT OF 9'-0" WITHIN LIMITS OF JANITORS CLOSET (AS IDENTIFIED BY LINETYPE / DIMENSIONS)
- 12 INSTALL 5/8" TILE BACKER BD. ON 2-1/2" MTL STUDS @ 16" O.C. ALONG LIMITS OF CMU IN ORDER TO RECEIVE FINISH WALL TILE RE: INTERIOR ELEVATIONS
- 13 CYLINDRICAL COLUMN FURRING TO RECEIVE GLASS TILE (GT-2), INSTALL FULL HEIGHT UP TO FINISH CEILING
- 14 WALL MTD. UNIT HEATER RE: MECH. DWGS.
- 15 NATURAL GAS METER RE: PLUMB. DWGS.
- 16 EXTERIOR CAST IRON CLEANOUT RE: PLUMB. DWGS.
- 17 FIRE DEPT. KNOX-BOX RE: FIRE PROTECTION DWGS.
- 18 OVERFLOW DOWNSPOUT NOZZLE RE: PLUMB. DWGS.
- 19 WALL HYDRANT RE: PLUMB. DWGS.
- 20 EXTERIOR ELECT. OUTLET RE: ELECT. DWGS.

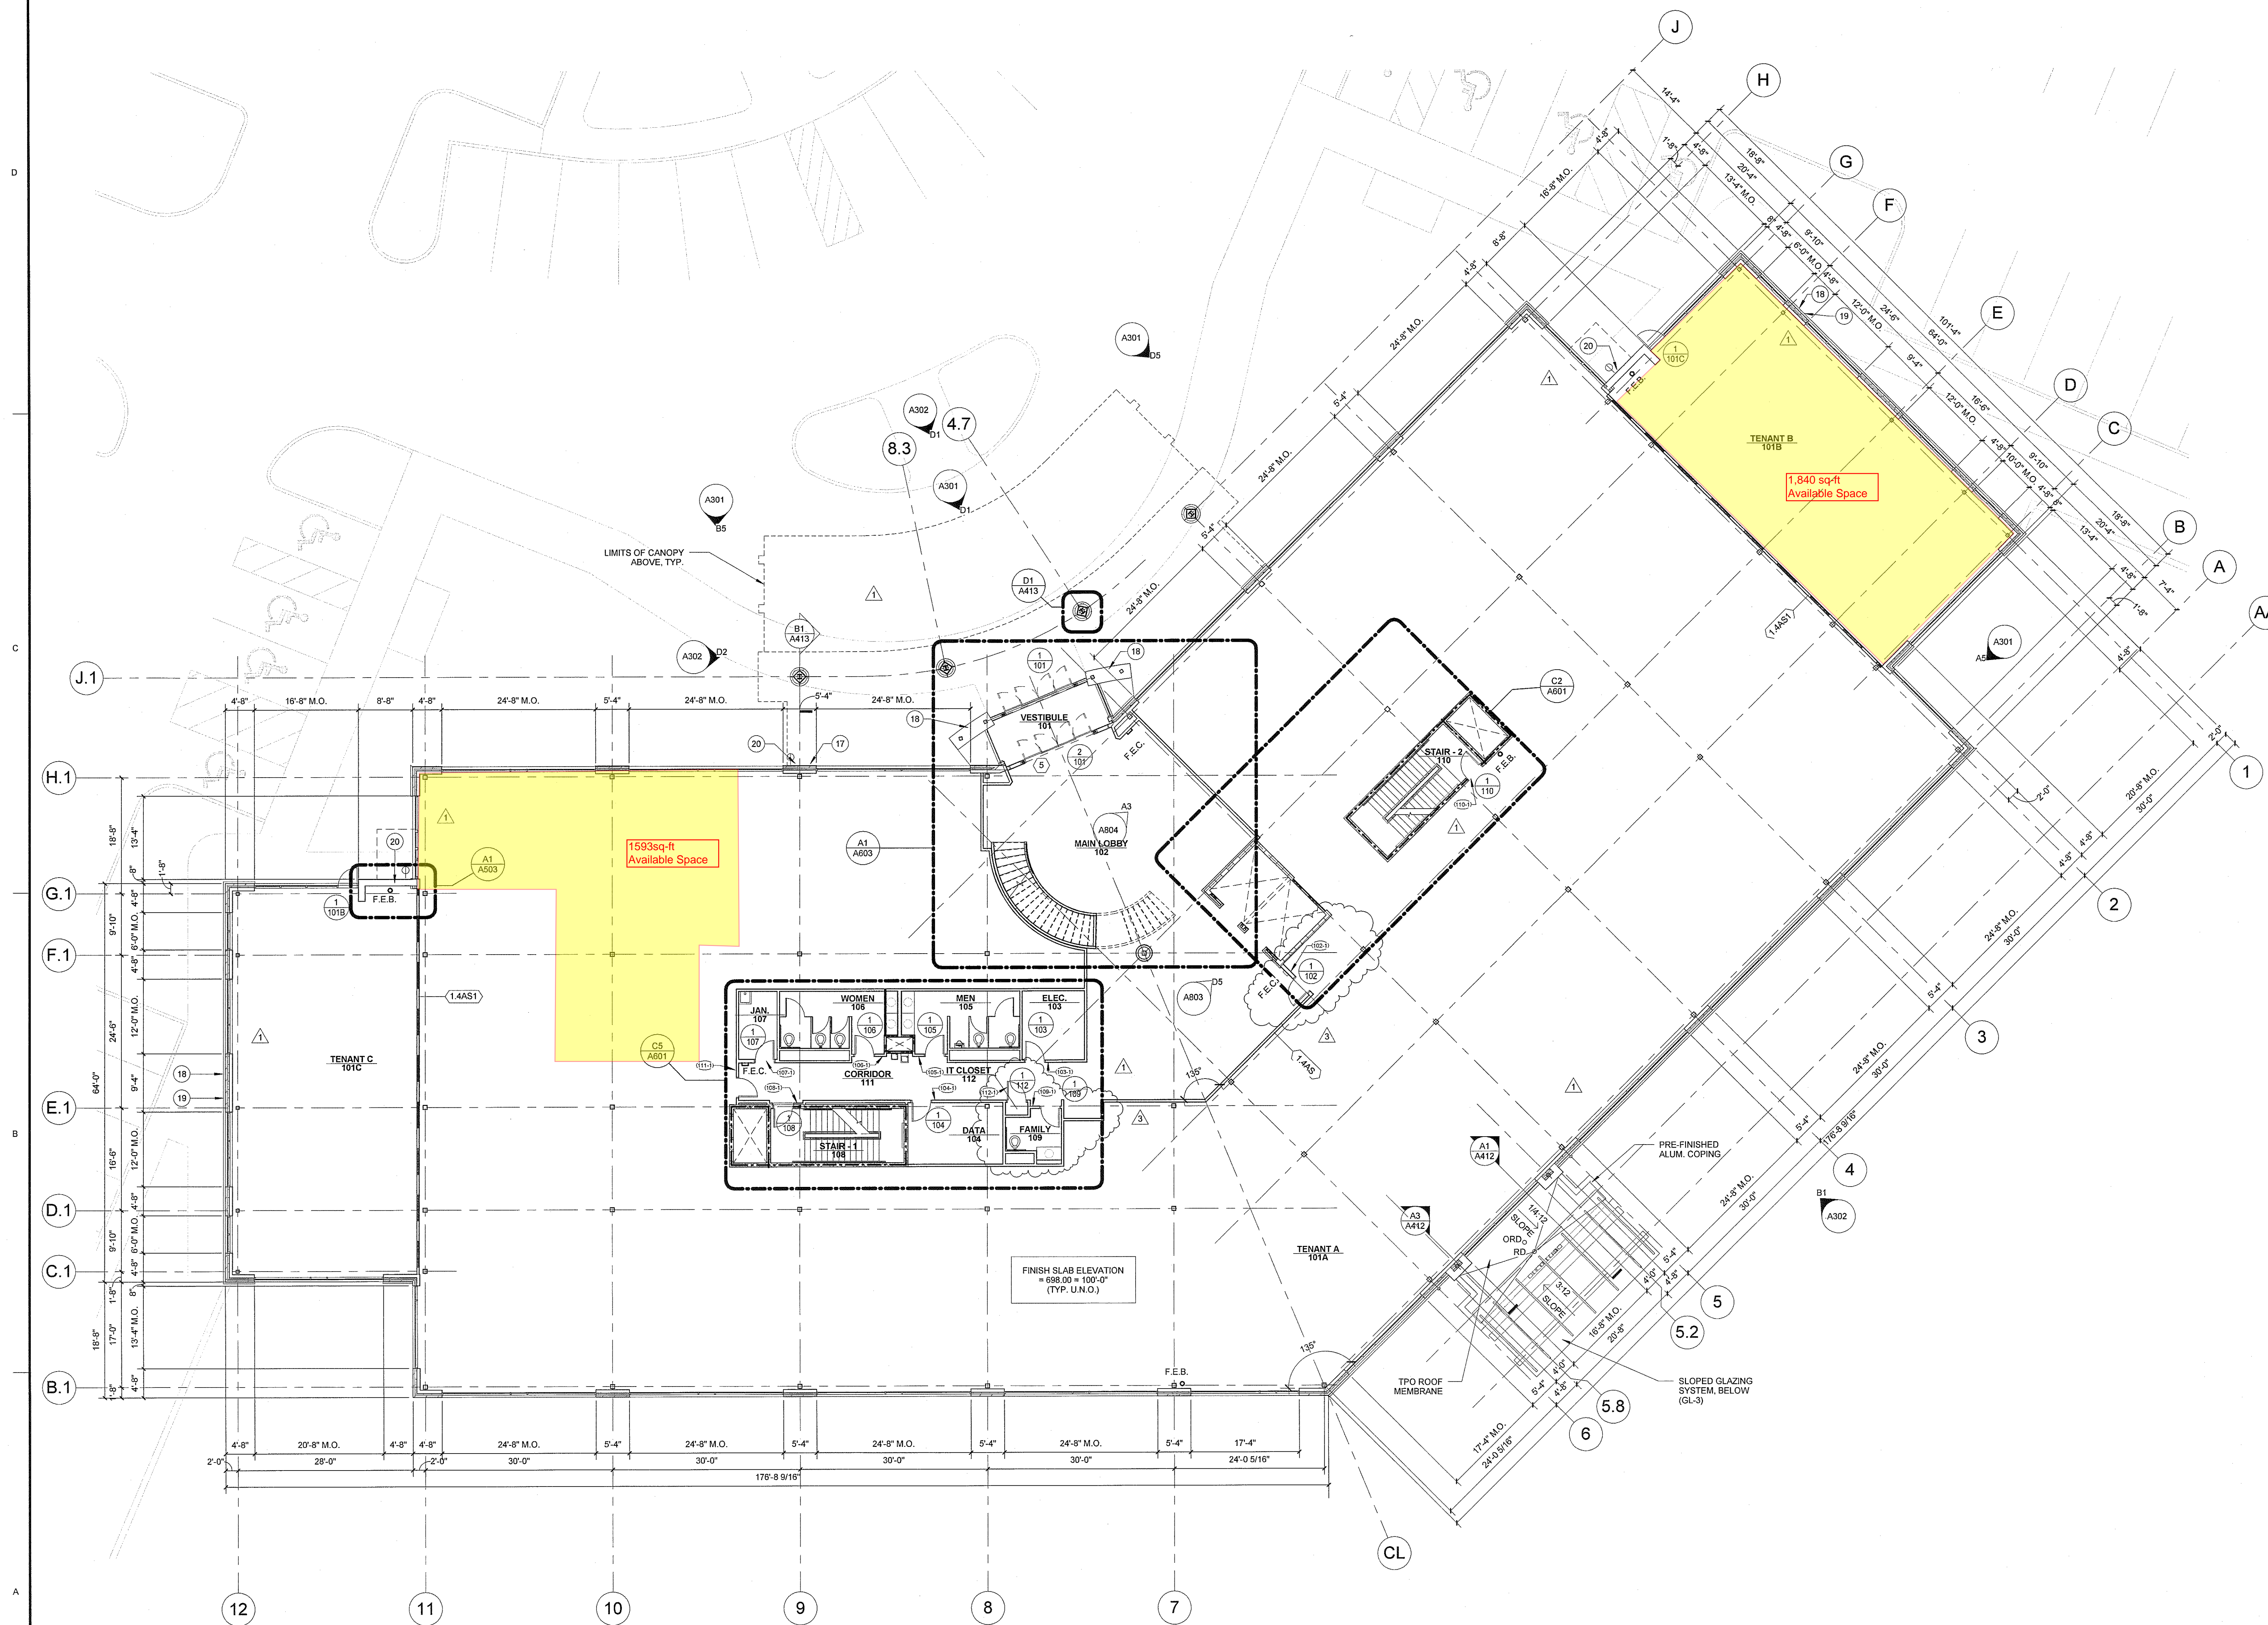

BOONE HOSPITAL MEDICAL OFFICE BUILDING
900 WEST NIFONG -
COLUMBIA, MISSOURI 65203

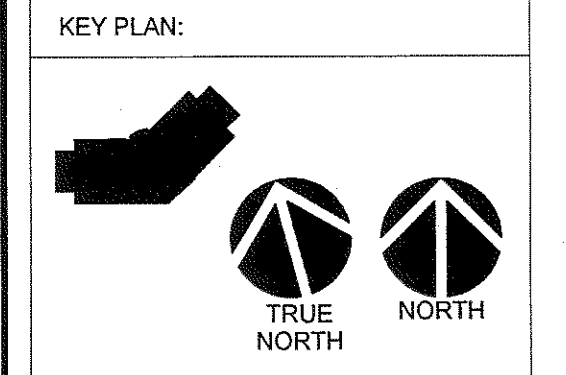

PROJECT NO:	A14026
DATE:	SEPT 12, 2014
DRAWN BY:	JH
CHECKED BY:	JPL
CHECKED BY:	PKL
REVISED DATE	DESCRIPTION
Oct. 03, 2014	ADDENDUM No. 01
Nov. 25, 2014	ADDENDUM No. 02

MAIN LEVEL FLOOR PLAN

A202

A1 MAIN LEVEL
SCALE: 3/32" = 1'-0"